

Received
JAN 03 2017
Planning Dept.

EXHIBIT "C"


LEGEND

PP Power Pole
GW Guy Wire
MH Manhole
WV Water Valve
TP Telephone Pedestal
WM Water Meter
FH Fire Hydrant
LP Light Pole
ICV Irrigation Valve
CO Clean Out
AC Air Conditioner
TV Cable Box
SB Signal Box
SP Signal Pole
SN Sign
IRF Iron Rod Found
IRS Iron Rod Set
SS Sanitary Sewer
SW Storm Sewer
EM Electric Meter

SULLIVAN
Architecture
Planning / Interiors

4436 BALLINGER DR
PLANO, TX 75093
(972) 612-7067 PHONE
(972) 612-9543 FAX
COPYRIGHT © 2016

Architect's Seal:

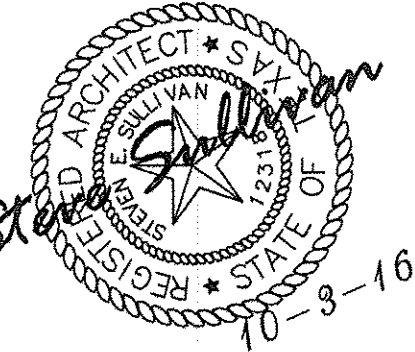

No.	Date	Revision
1	10-7-16	ADDN.-1
2	11-11-16	ADDN.-2
3	12-22-16	ADDN.-3

NOTICE:
THESE DRAWINGS, AS INSTRUMENTS OF SERVICE, ARE THE EXCLUSIVE PROPERTY OF THE ARCHITECT AND ARE NOT TO BE USED IN WHOLE OR PART WITHOUT THE ARCHITECT'S EXPRESS WRITTEN PERMISSION. UNAUTHORIZED USE OF THESE DRAWINGS WILL BE SUBJECT TO LEGAL REMEDY BEING SOUGHT BY THE ARCHITECT.
WRITTEN DIMENSIONS ON THESE DRAWINGS SHALL TAKE PRECEDENCE OVER SCALED DIMENSIONS.
CONTRACTORS SHALL VERIFY AND BE RESPONSIBLE FOR ALL DIMENSIONS ON THE JOB AND THIS OFFICE MUST BE NOTIFIED OF ANY VARIATIONS FROM THE DIMENSIONS AND CONDITIONS SHOWN.
SHOP DETAILS MUST BE SUBMITTED TO THIS OFFICE AND TO THE OWNER'S REPRESENTATIVE FOR APPROVAL BEFORE PROCEEDING WITH FABRICATION.

MOVE-IT SELF STORAGE
Renovations
2422 ROBINSON ROAD
GRAND PRAIRIE, TEXAS

CONSULTANT:
10-3-16
ISSUED FOR
PERMIT REVIEW
&
CONSTRUCTION

Job No. 1620	Issue Date: ---
Drawn By S.S.	Scale: ---
Checked By S.S.	
Project Mgr. S.S.	

Sheet Title
**EXISTING
SITE PLAN**

Sheet No.

A1.02

SHEET SIZE: 24" X 36"

CURVE	RADIUS	CHORD BEARING	CHORD LENGTH	DELTA ANGLE	ARC LENGTH
C1	60.0000'	N 75°00'00" E	115.9111'	150°00'00"	157.0796'

Oak Tembers Apartments


Texas Utility
3.694' Acres




0' 30' 60' 120'
Scale 1"=60'

LEGEND

Power Pole
Guy Wire
Manhole
Water Valve
Telephone Pedestal
Water Meter
Fire Hydrant
Light Pole
Irrigation Valve
Clean Out

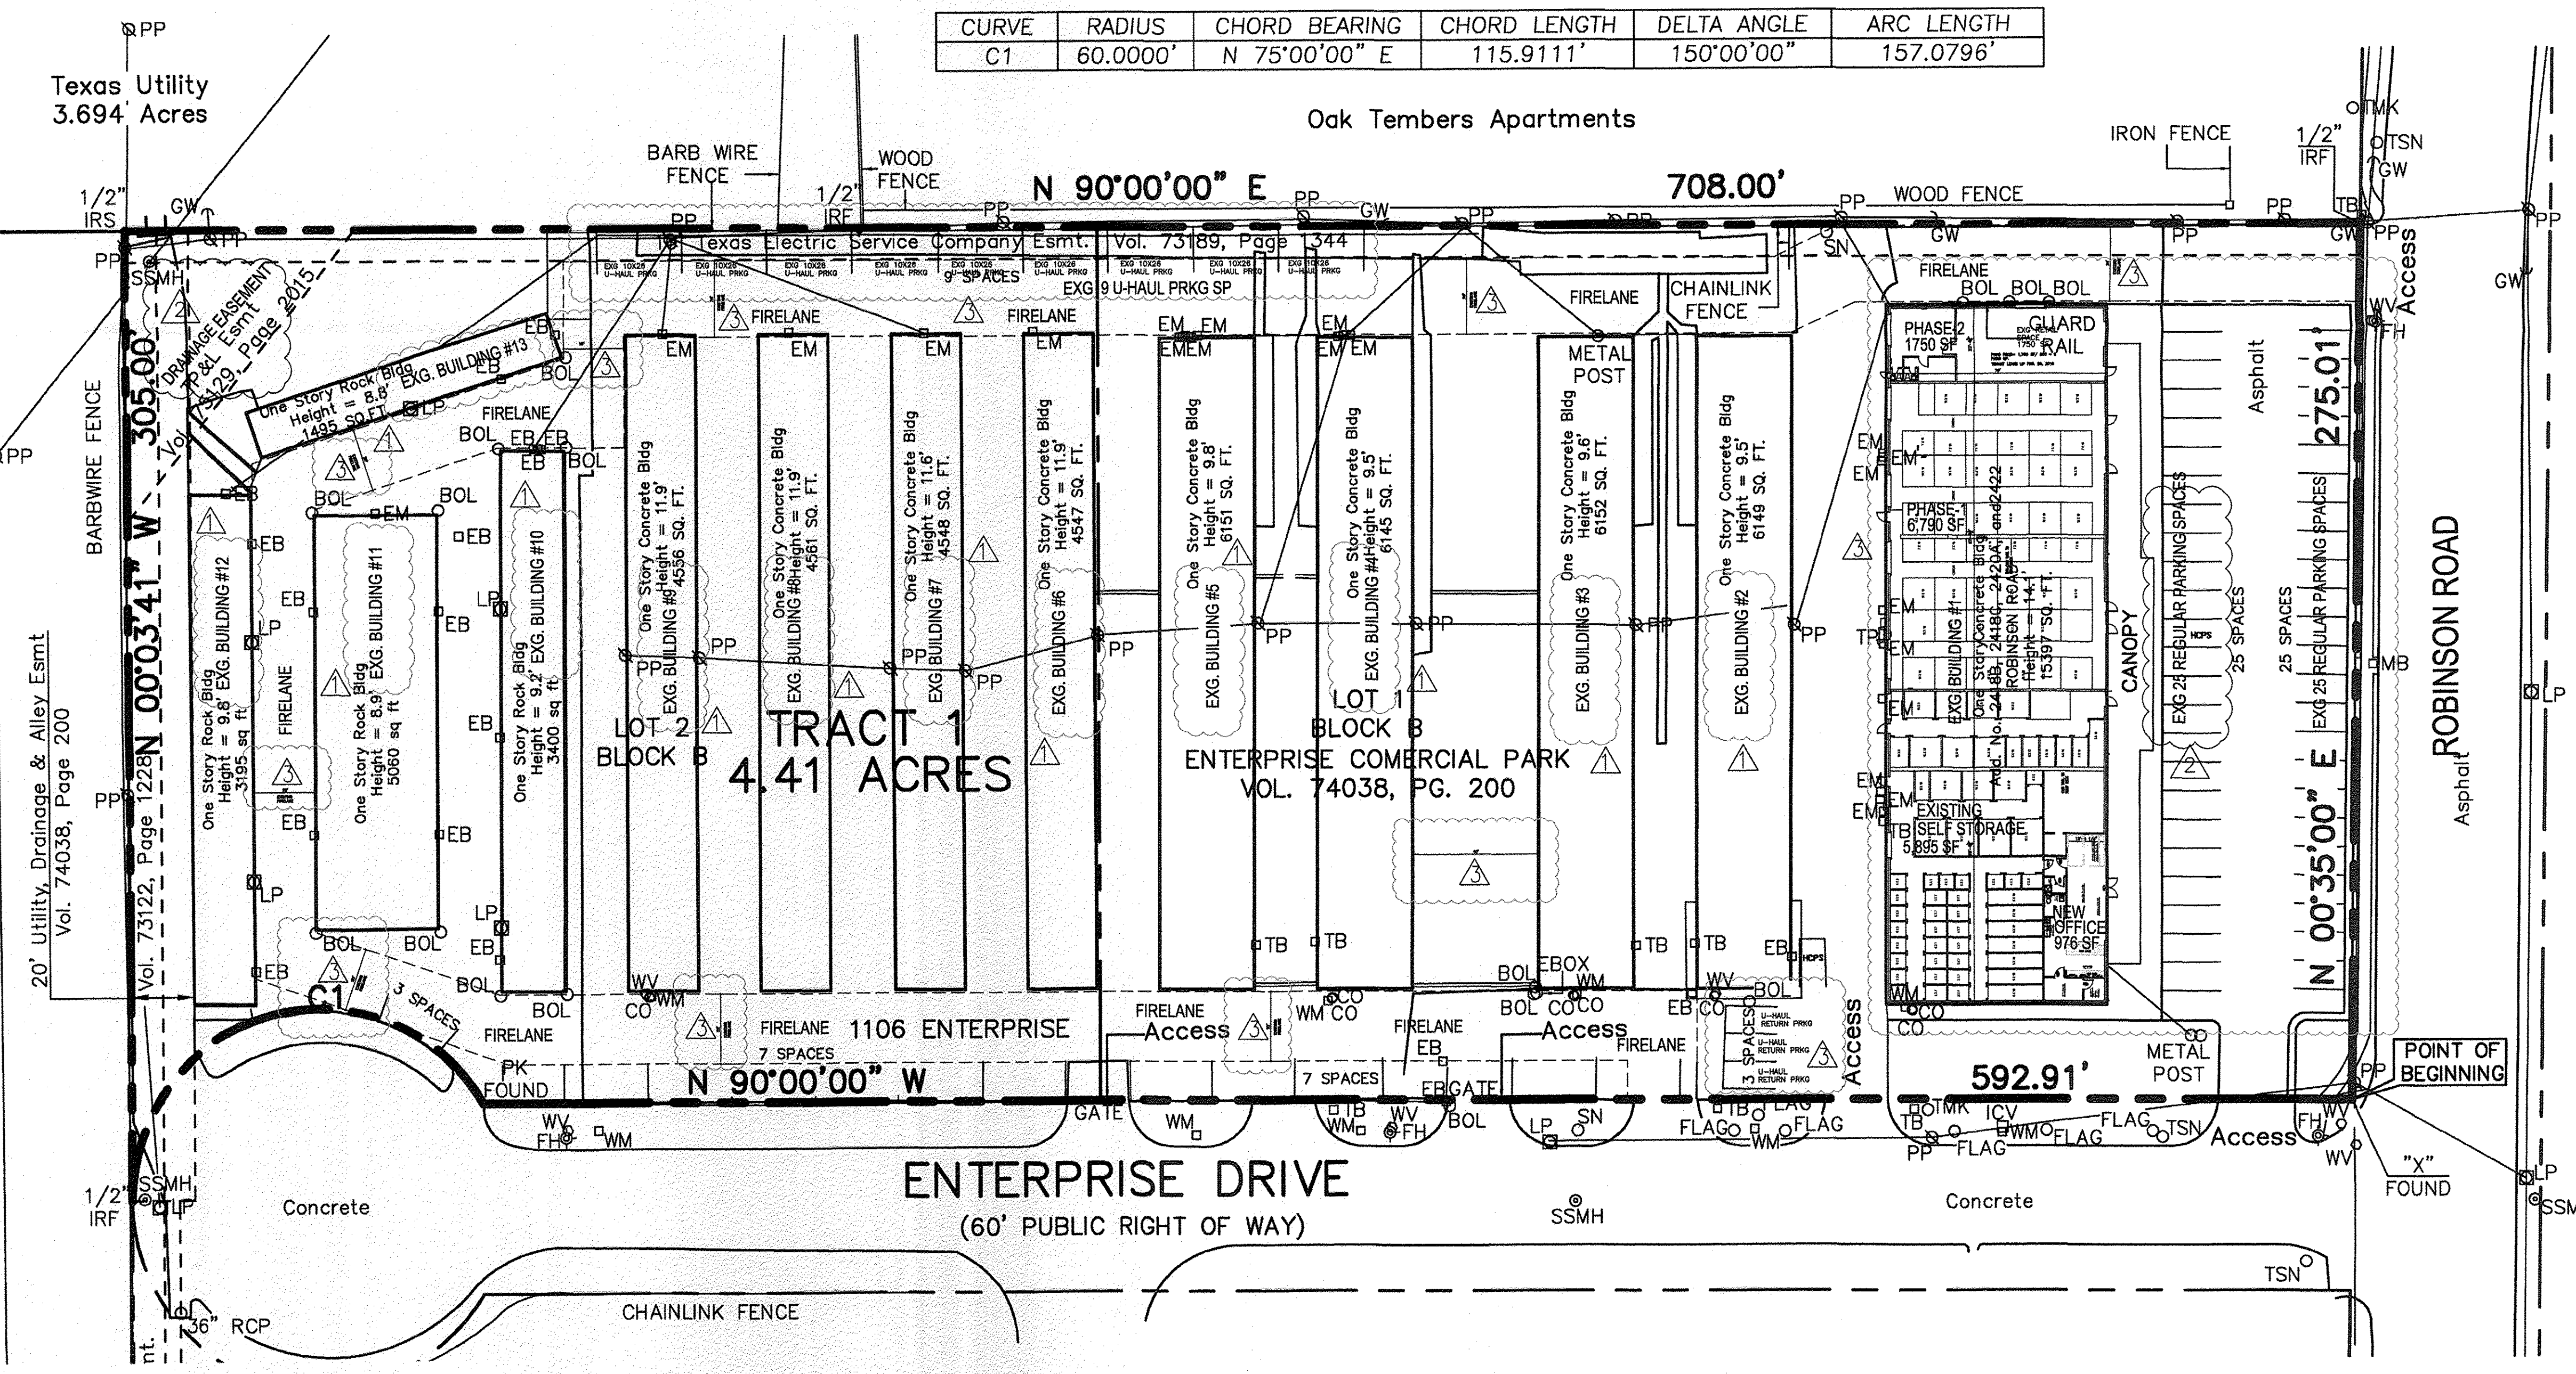

01 SITE PLAN
Scale: 1/32"=1'-0"

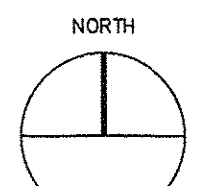

CASE #: SUI61203