

Exhibit B - Site Plan

Received
JAN 03 2017
Planning Dept.

LEGEND

PP	Power Pole
GW	Guy Wire
MH	Manhole
WV	Water Valve
TP	Telephone Pedestal
WM	Water Meter
FH	Fire Hydrant
LP	Light Pole
ICV	Irrigation Valve
CO	Clean Out
AC	Air Conditioner
TV	Cable Box
SB	Signal Box
SP	Signal Pole
SN	Sign
IRF	Iron Rod Found
IRS	Iron Rod Set
SS	Sanitary Sewer
SW	Storm Sewer
EM	Electric Meter

SULLIVAN
Architecture
Planning / Interiors
4436 BALLINGER DR
PLANO, TX 75093
(972) 612-7007 PHONE
(972) 612-0543 FAX
COPYRIGHT © 2016



No.	Date	Revision
10-7-16		ADDN-1
11-11-16		ADDN-2
12-22-16		ADDN-3

NOTICE:
THIS DRAWING, AS INSTRUMENT OF SERVICE, AND THE EXISTING CONDITIONS AND RECORDS ON FILE WITH THE CITY OF PLANO, TEXAS, ARE THE SOLE PROPERTY OF SULLIVAN ARCHITECTURE, PLLC. NO PART OF THIS DRAWING OR ANY INFORMATION CONTAINED HEREIN IS TO BE REPRODUCED OR TRANSMITTED IN ANY FORM OR BY ANY MEANS, ELECTRONIC OR MECHANICAL, INCLUDING PHOTOCOPYING, RECORDING, OR BY ANY INFORMATION STORAGE AND RETRIEVAL SYSTEM, WITHOUT THE WRITTEN PERMISSION OF SULLIVAN ARCHITECTURE, PLLC. ANY SUCH REPRODUCTION OR TRANSMISSION WITHOUT THE WRITTEN PERMISSION OF SULLIVAN ARCHITECTURE, PLLC, IS PROHIBITED. SULLIVAN ARCHITECTURE, PLLC, SHALL BE RESPONSIBLE FOR THE ACCURACY OF THE INFORMATION CONTAINED HEREIN. SULLIVAN ARCHITECTURE, PLLC, SHALL NOT BE RESPONSIBLE FOR THE ACCURACY OF THE INFORMATION CONTAINED HEREIN.

MOVE-IT SELF STORAGE
Renovations
2422 ROBINSON ROAD
GRAND PRAIRIE, TEXAS

CONSULTANT:
10-3-16
ISSUED FOR
PERMIT REVIEW
&
CONSTRUCTION

Job No.	Issue Date
1620	---
Drawn By	Scale:
S.S.	
Checked By	
S.S.	
Project Mgr.	
S.S.	


Sheet Title:
EXISTING
SITE PLAN

Sheet No.

A1.02

SHEET SIZE: 24" X 36"

CURVE	RADIUS	CHORD BEARING	CHORD LENGTH	DELTA ANGLE	ARC LENGTH
C1	60.0000'	N 75°00'00" E	115.9111'	150°00'00"	157.0796'

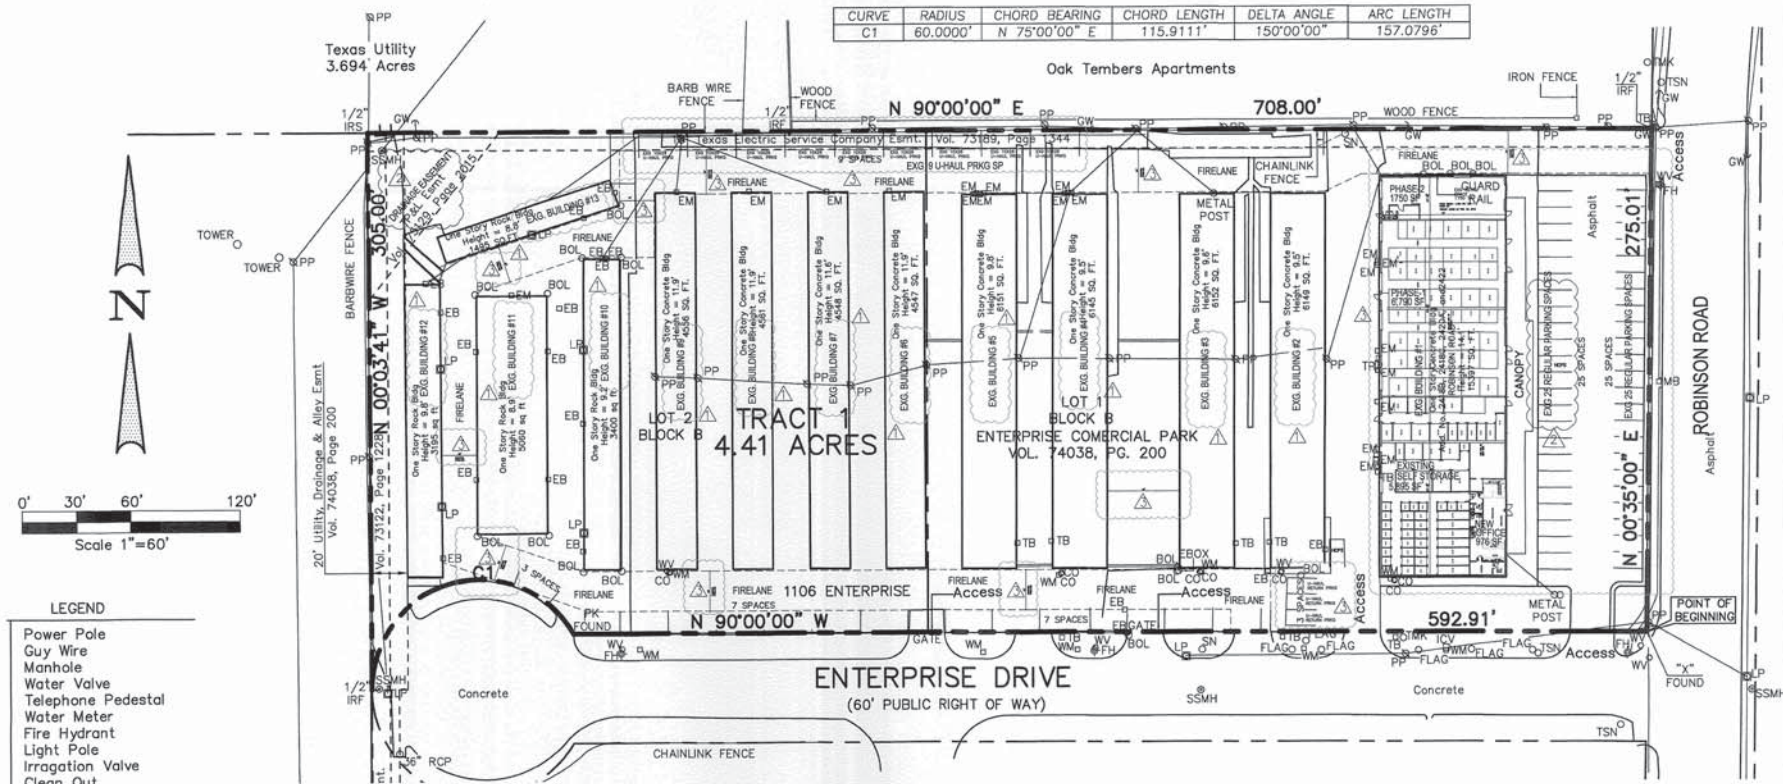

01 SITE PLAN
Scale: 1/32"=1'-0"

CASE #: SUI61203